



REVISIONS	BY

**GENERAL NOTES**

A. PHOTOMETRIC CALCULATIONS ARE PROVIDED FOR OWNER REFERENCE ONLY. THIS SHEET WILL NOT BE PART OF THE CONSTRUCTION DOCUMENTS.

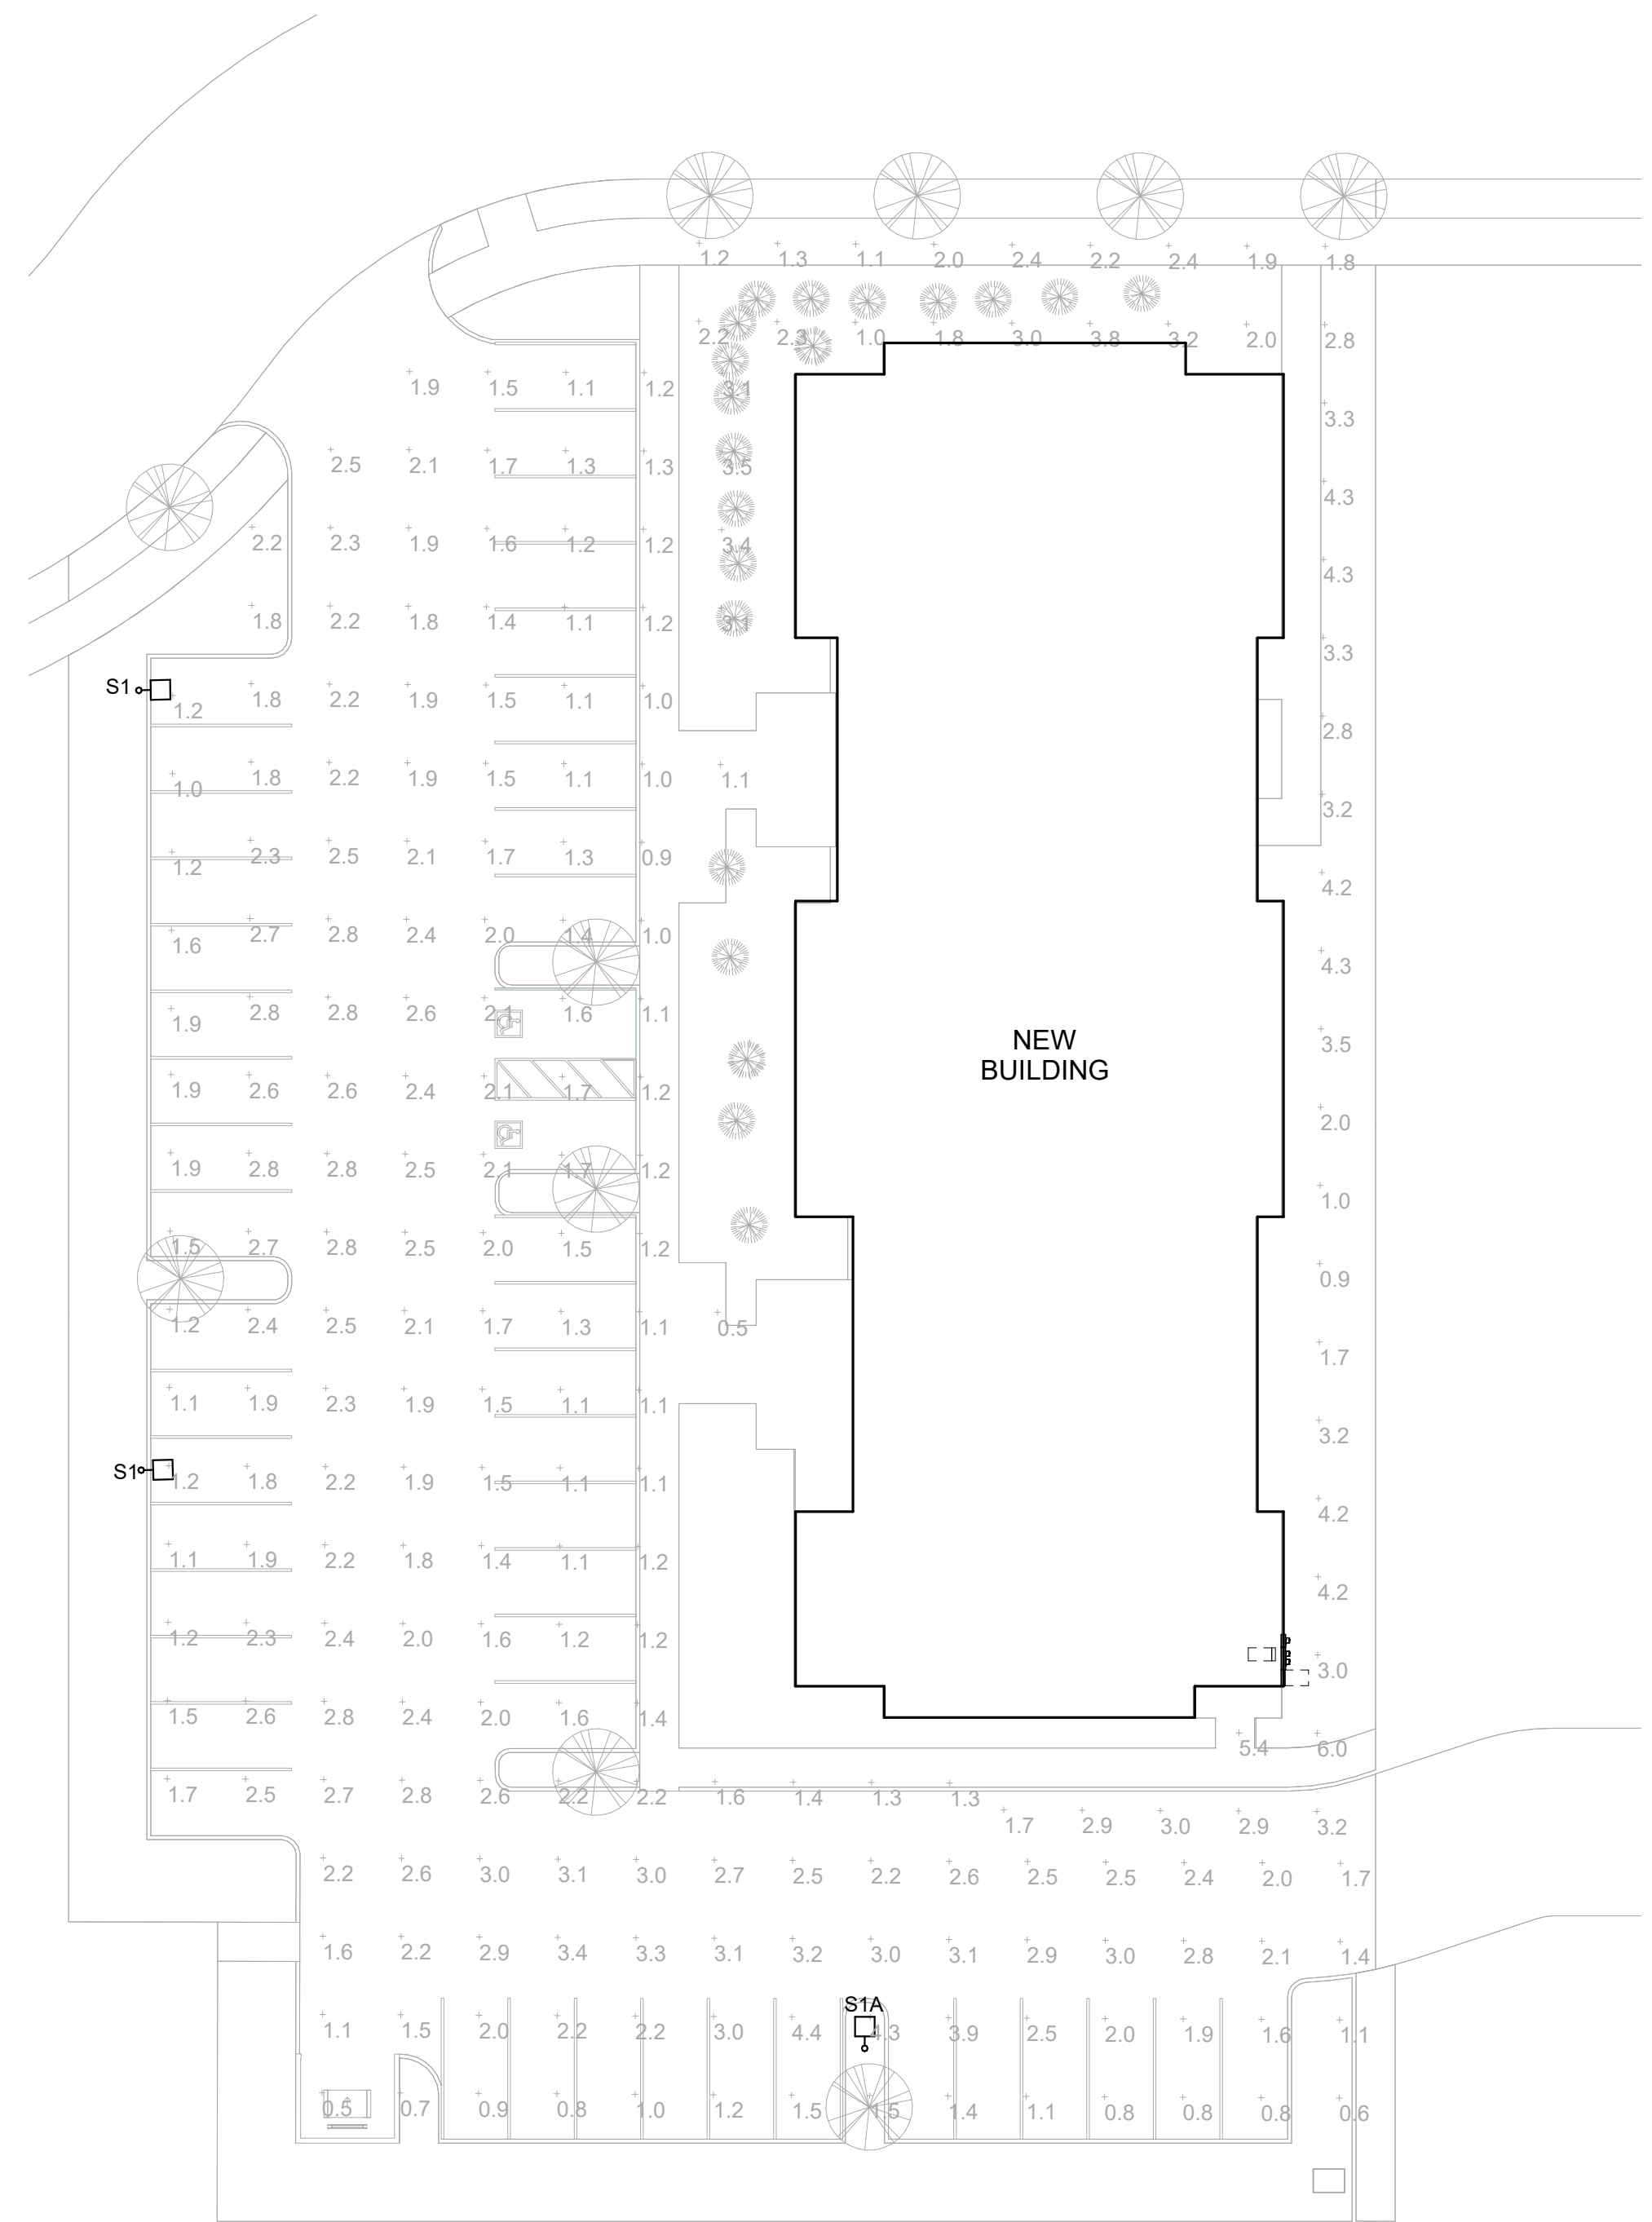

**SITE PLAN - PHOTOMETRICS**

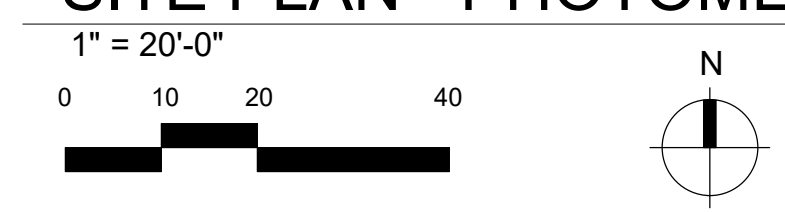


**PCI** Pennell Consulting, Inc.  
 Electrical and Electronics System Design  
 403 S. Jefferson, Suite 301  
 Spokane, WA 99204  
 (T) 509.747.1888 (F) 509.747.1872

**MJNEAL ASSOCIATES**  
 ARCHITECTS, PLLC

509.663.6455  
 MJNEAL@MJNEALAI.A.COM  
 WWW.MJNEALAI.A.COM  
 P.O. BOX 1945  
 WENATCHEE, WA 98807

© Copyright 2021

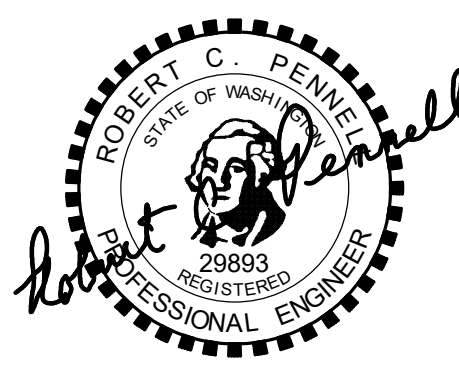

**MARYSVILLE DENTAL OFFICES  
 DENTAL OFFICE  
 MARYSVILLE, WASHINGTON**

Date:	2022-05-19
Scale Factor:	1
Drawn:	KVT
File:	20479

Sheet  
**E1.2**